


**MAIN FLOOR**  
SCALE: 3/16" = 1'-0"

As Built Changes Under Consideration  
Sheet E-2, First Floor Lighting Plan  
11/17/2023

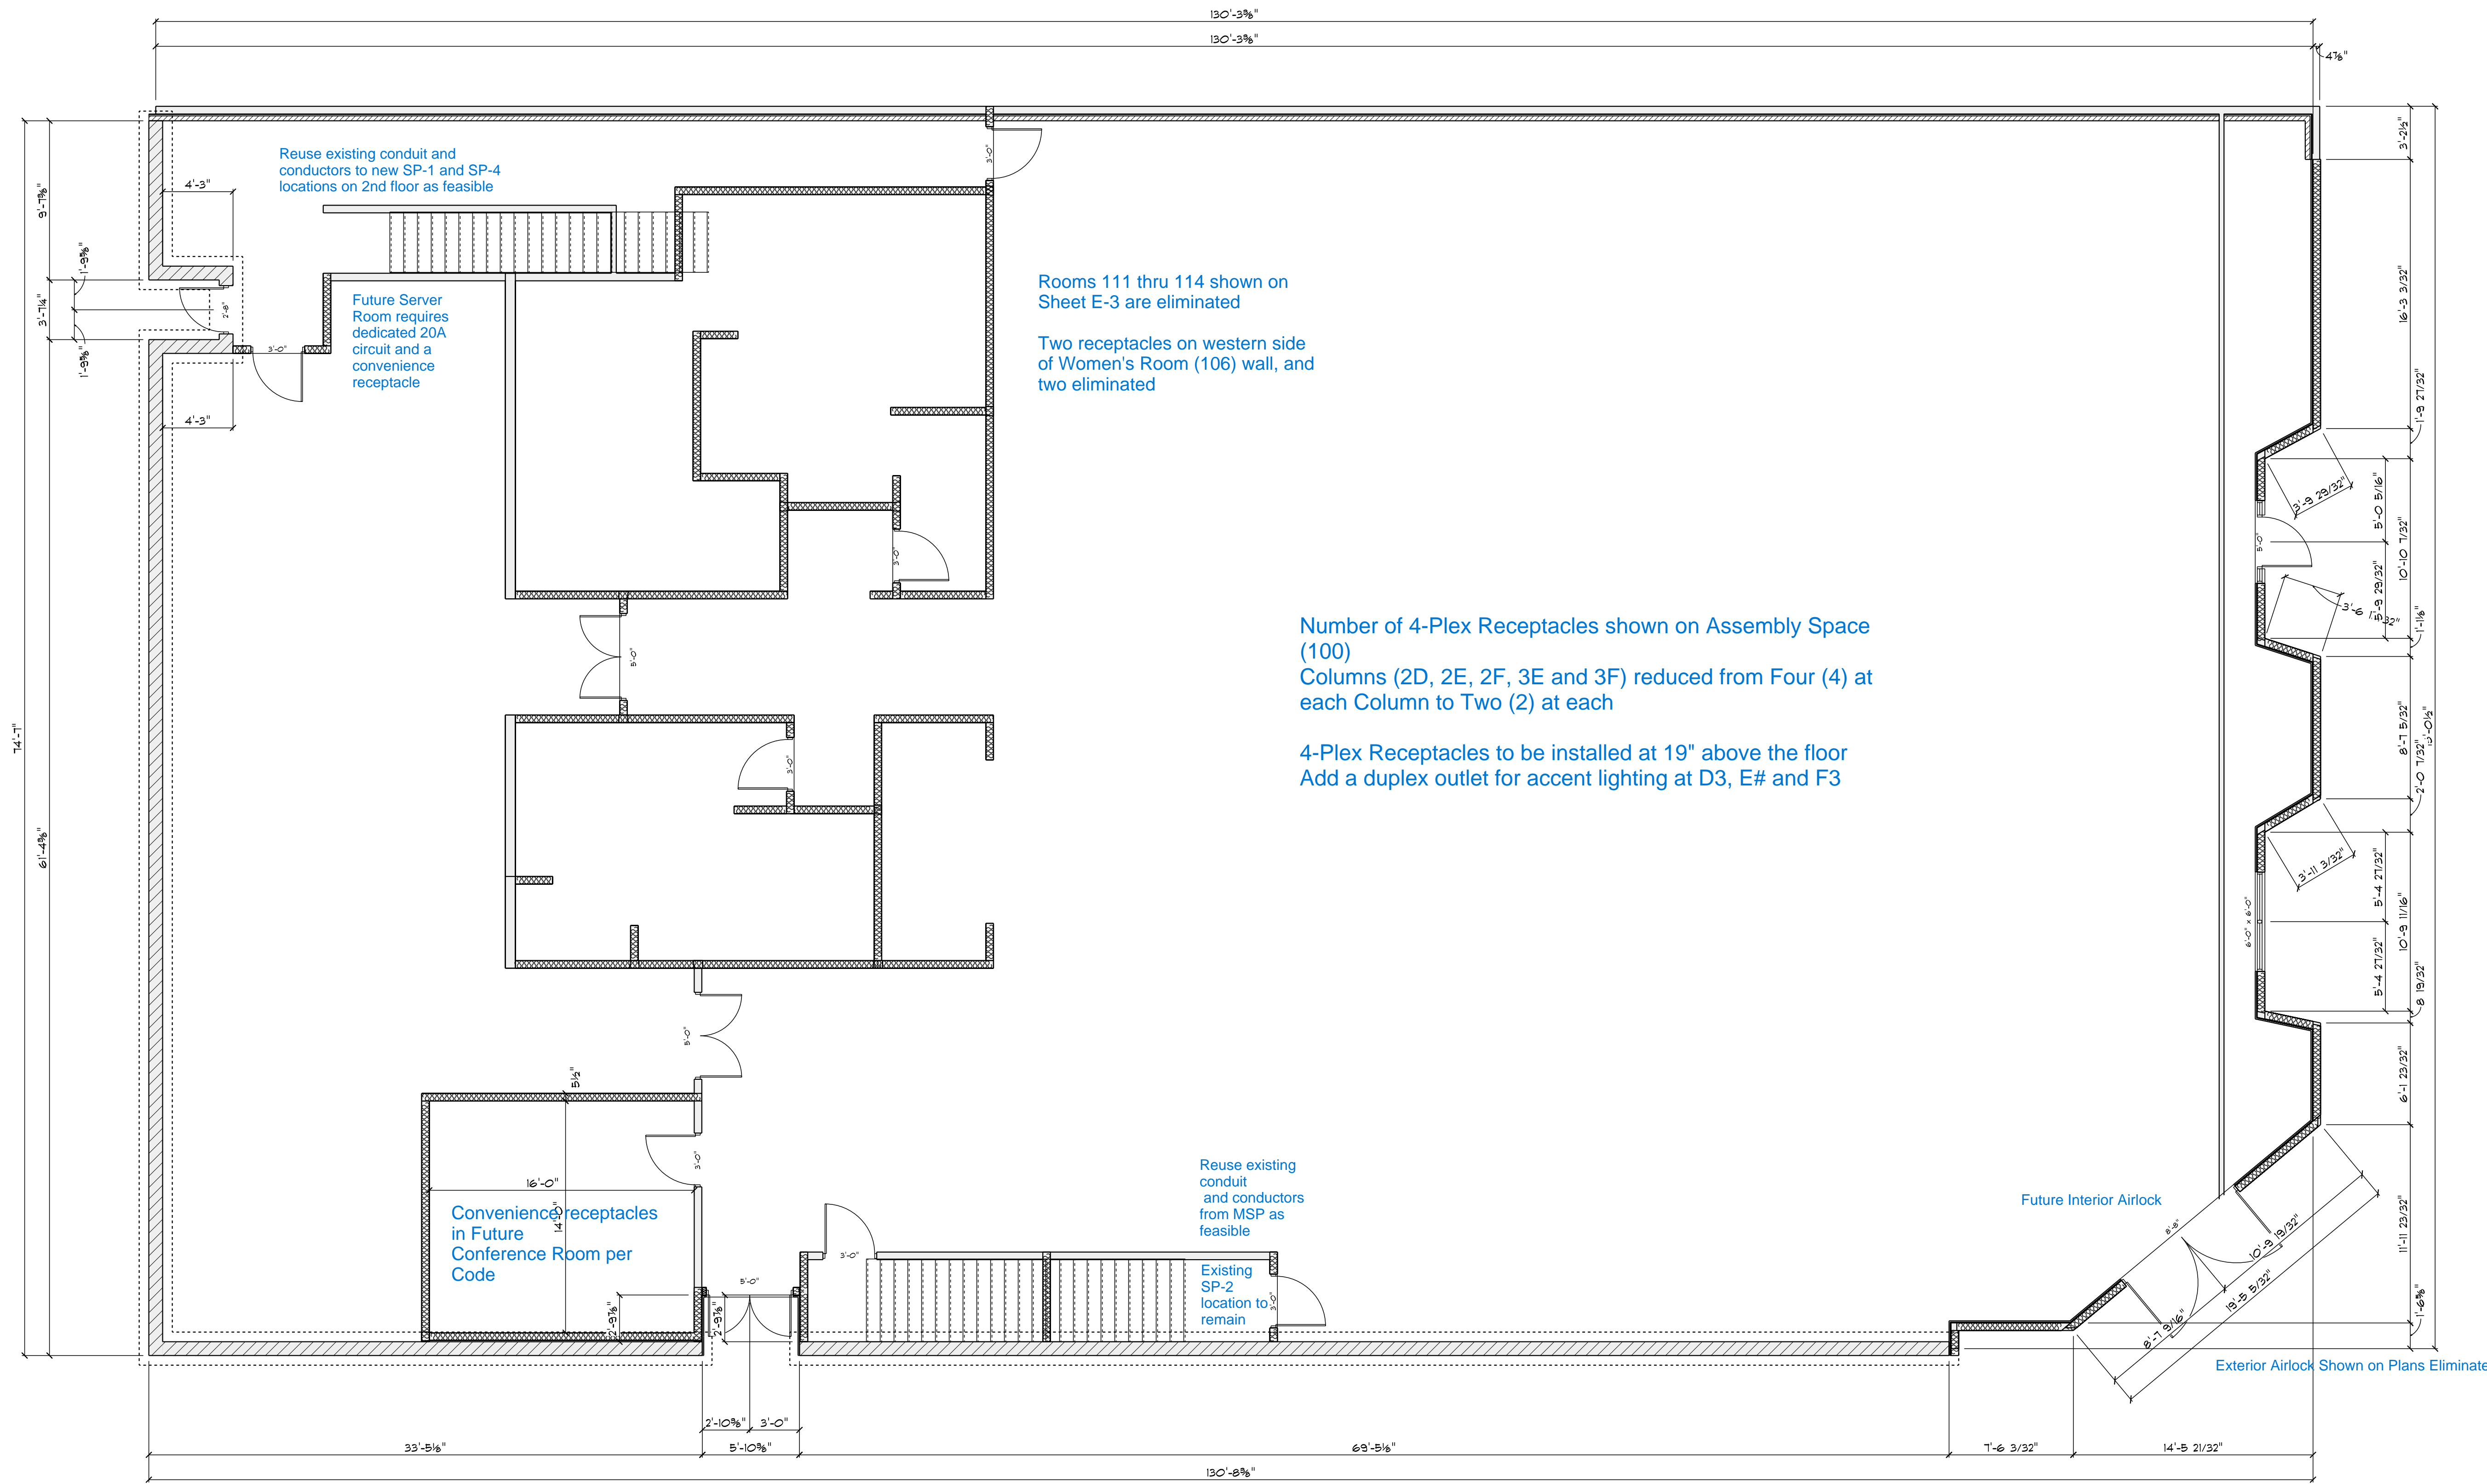

**MAIN FLOOR**  
SCALE: 3/16" = 1'-0"

Reuse existing conduit and conductors to new SP-1 and SP-4 locations on 2nd floor as feasible

Future Server Room requires dedicated 20A circuit and a convenience receptacle

Rooms 111 thru 114 shown on Sheet E-3 are eliminated

Two receptacles on western side of Women's Room (106) wall, and two eliminated

Number of 4-Plex Receptacles shown on Assembly Space (100)  
Columns (2D, 2E, 2F, 3E and 3F) reduced from Four (4) at each Column to Two (2) at each

4-Plex Receptacles to be installed at 19" above the floor  
Add a duplex outlet for accent lighting at D3, E# and F3

Convenience receptacles in Future Conference Room per Code

Reuse existing conduit and conductors from MSP as feasible

Existing SP-2 location to remain

Future Interior Airlock

Exterior Airlock Shown on Plans Eliminated

As Built Changes Under Consideration

Sheet E-3, First Floor Plan Electrical Power

11/17/2023